

1 LIBRARY CAFE  
1/4" = 1'-0"

FIRST FLOOR PLAN


PROJECT NO.	178001
DATE	01/30/2018
DRAWING NO.	


A100

SENIOR HIGH SCHOOL  
FOR  
PLUM BOROUGH SCHOOL DISTRICT  
900 ELICKER ROAD  
PLUM, PA 15239

ARCHITECTS

VEBH ARCHITECTS, P.C.  
470 Washington Road  
Pittsburgh, PA 15228  
412.561.7117  
www.vebh.com

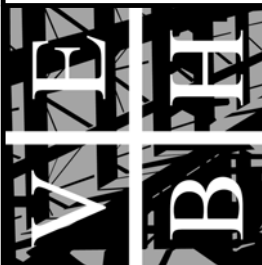

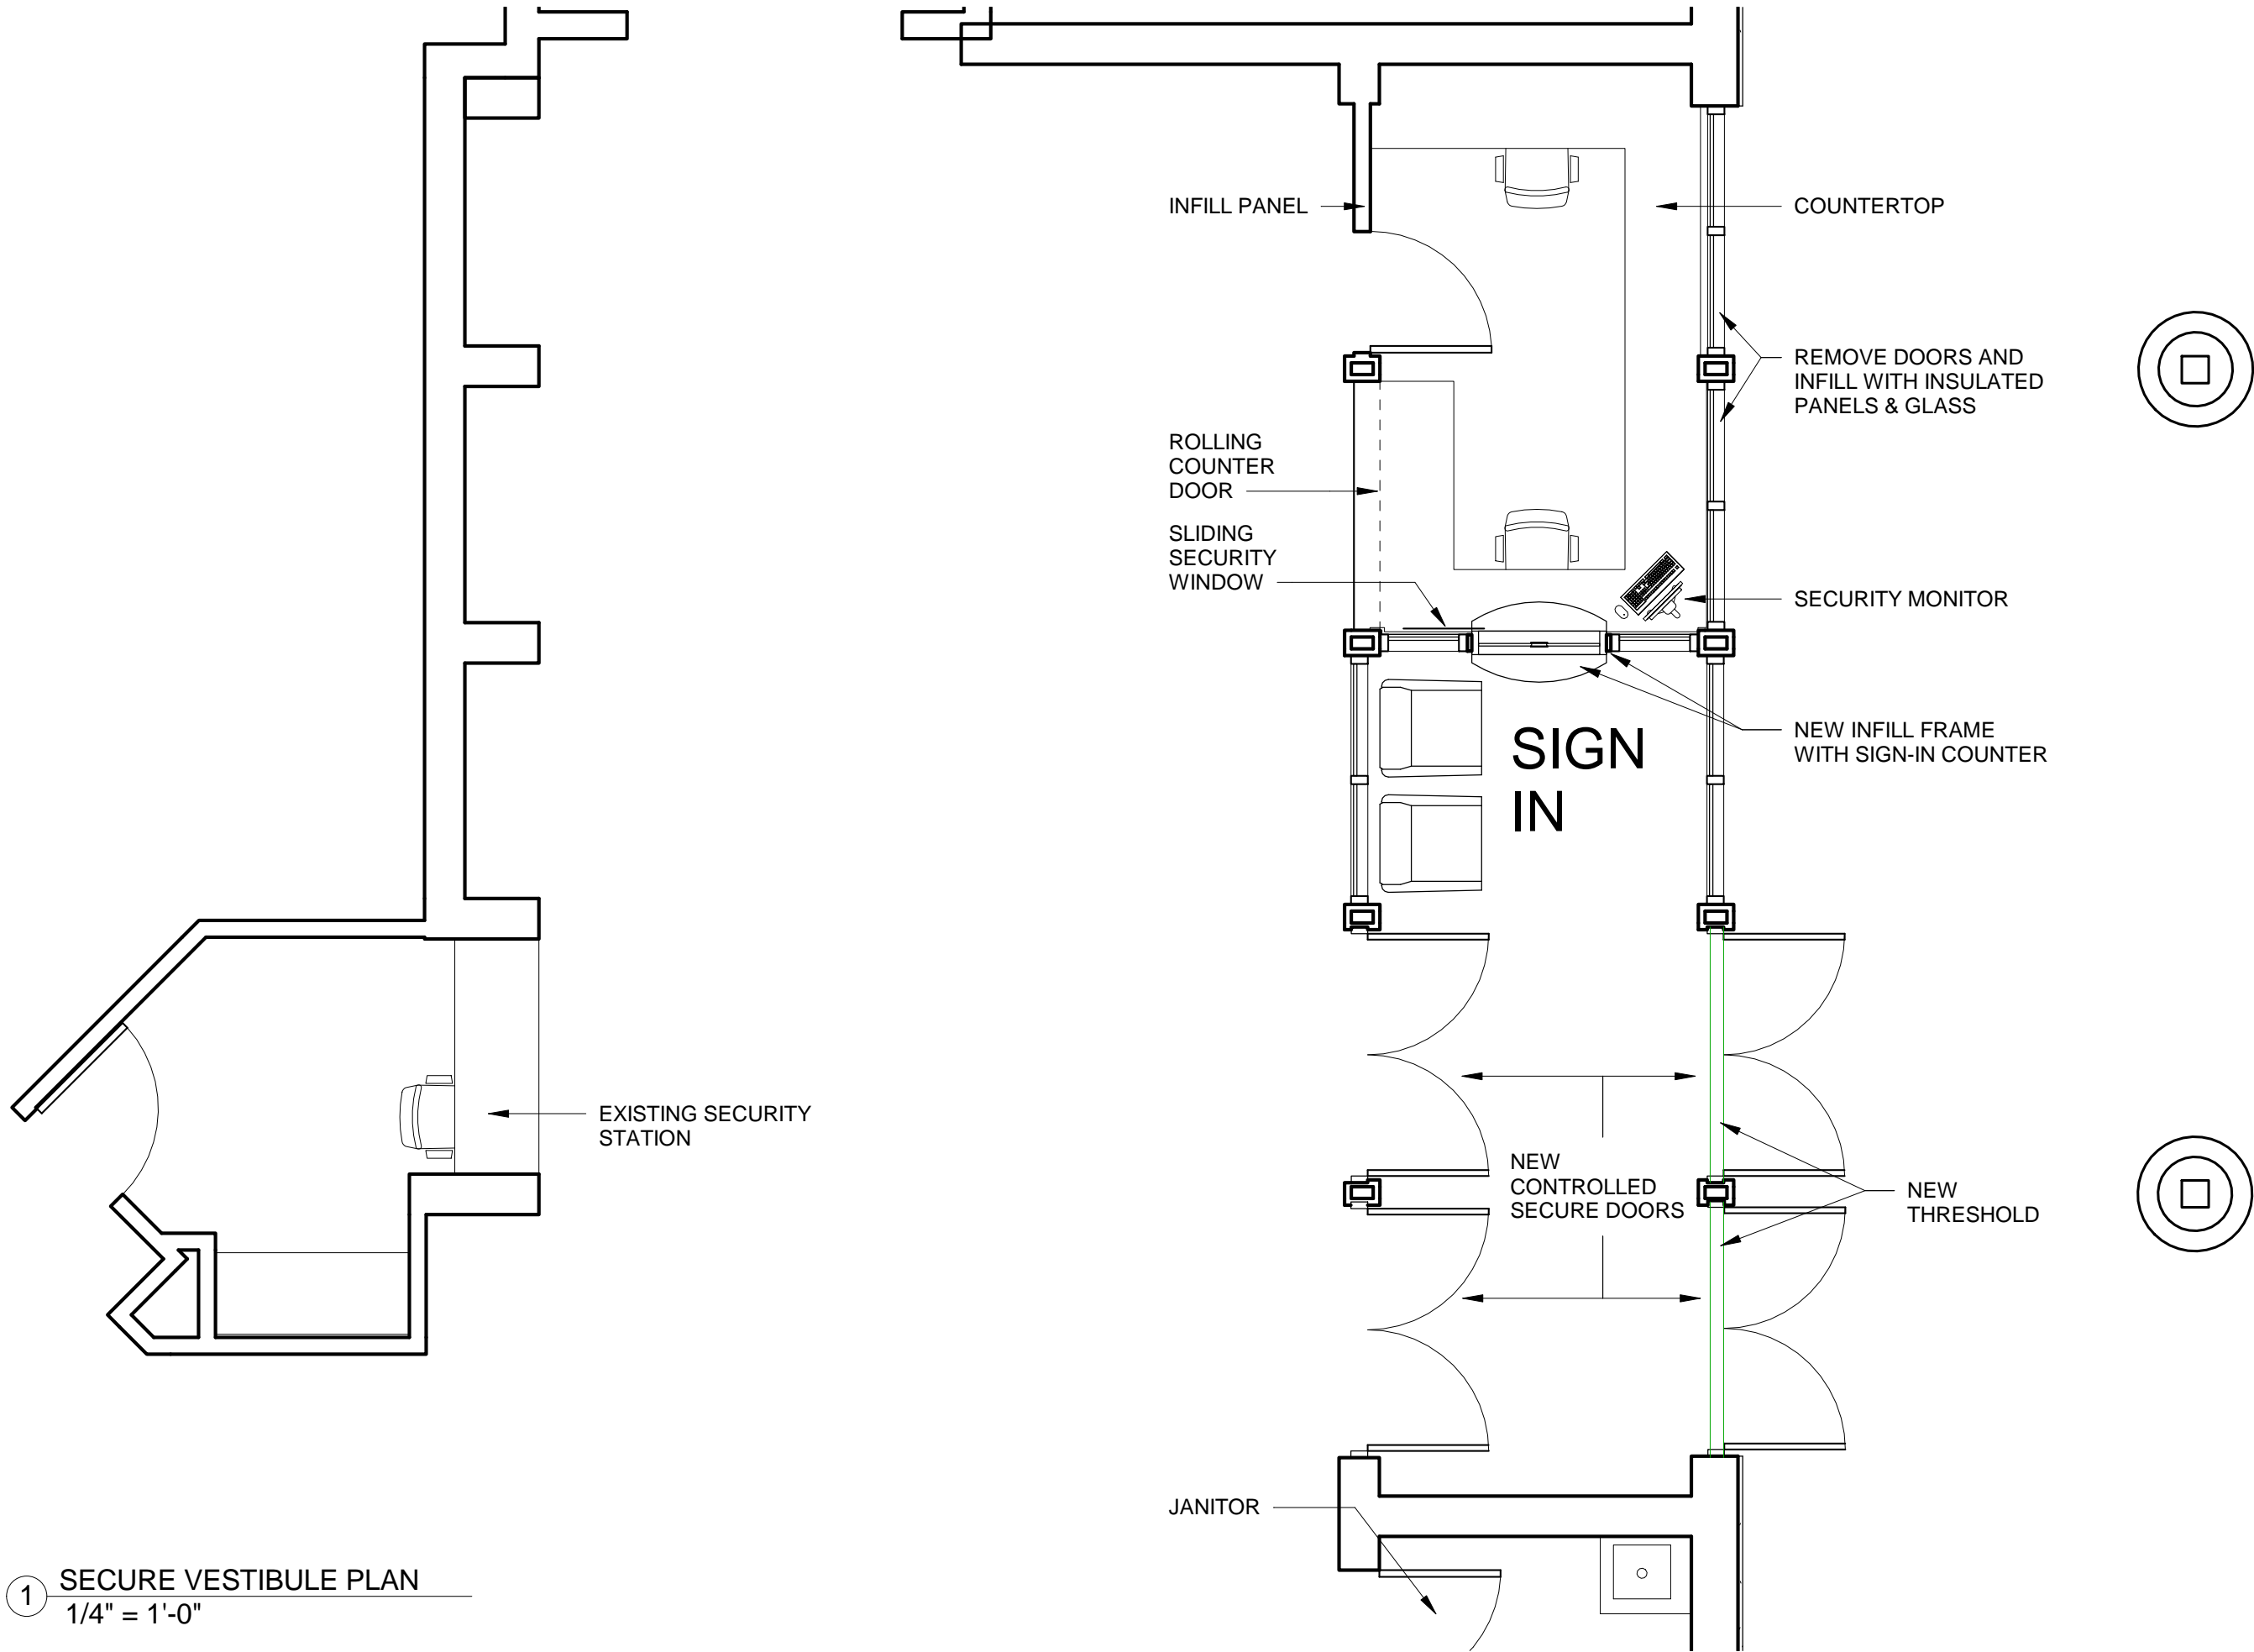

1 SECURE VESTIBULE PLAN  
1/4" = 1'-0"

ARCHITECTS	SECURE VESTIBULE PLAN		
	SENIOR HIGH SCHOOL FOR PLUM BOROUGH SCHOOL DISTRICT		
	900 ELICKER ROAD PLUM, PA 15239		
VEBH ARCHITECTS, P.C. 470 Washington Road Pittsburgh, PA 15228 412.561.7117 www.vebh.com	PROJECT NO.	178001	DRAWING NO.
	DATE	01/30/2018	
	WORK WITH SHEET		